



01 FIRST FLOOR PLAN (ELECTRICAL)

SCALE: 1/4" = 1'-0"

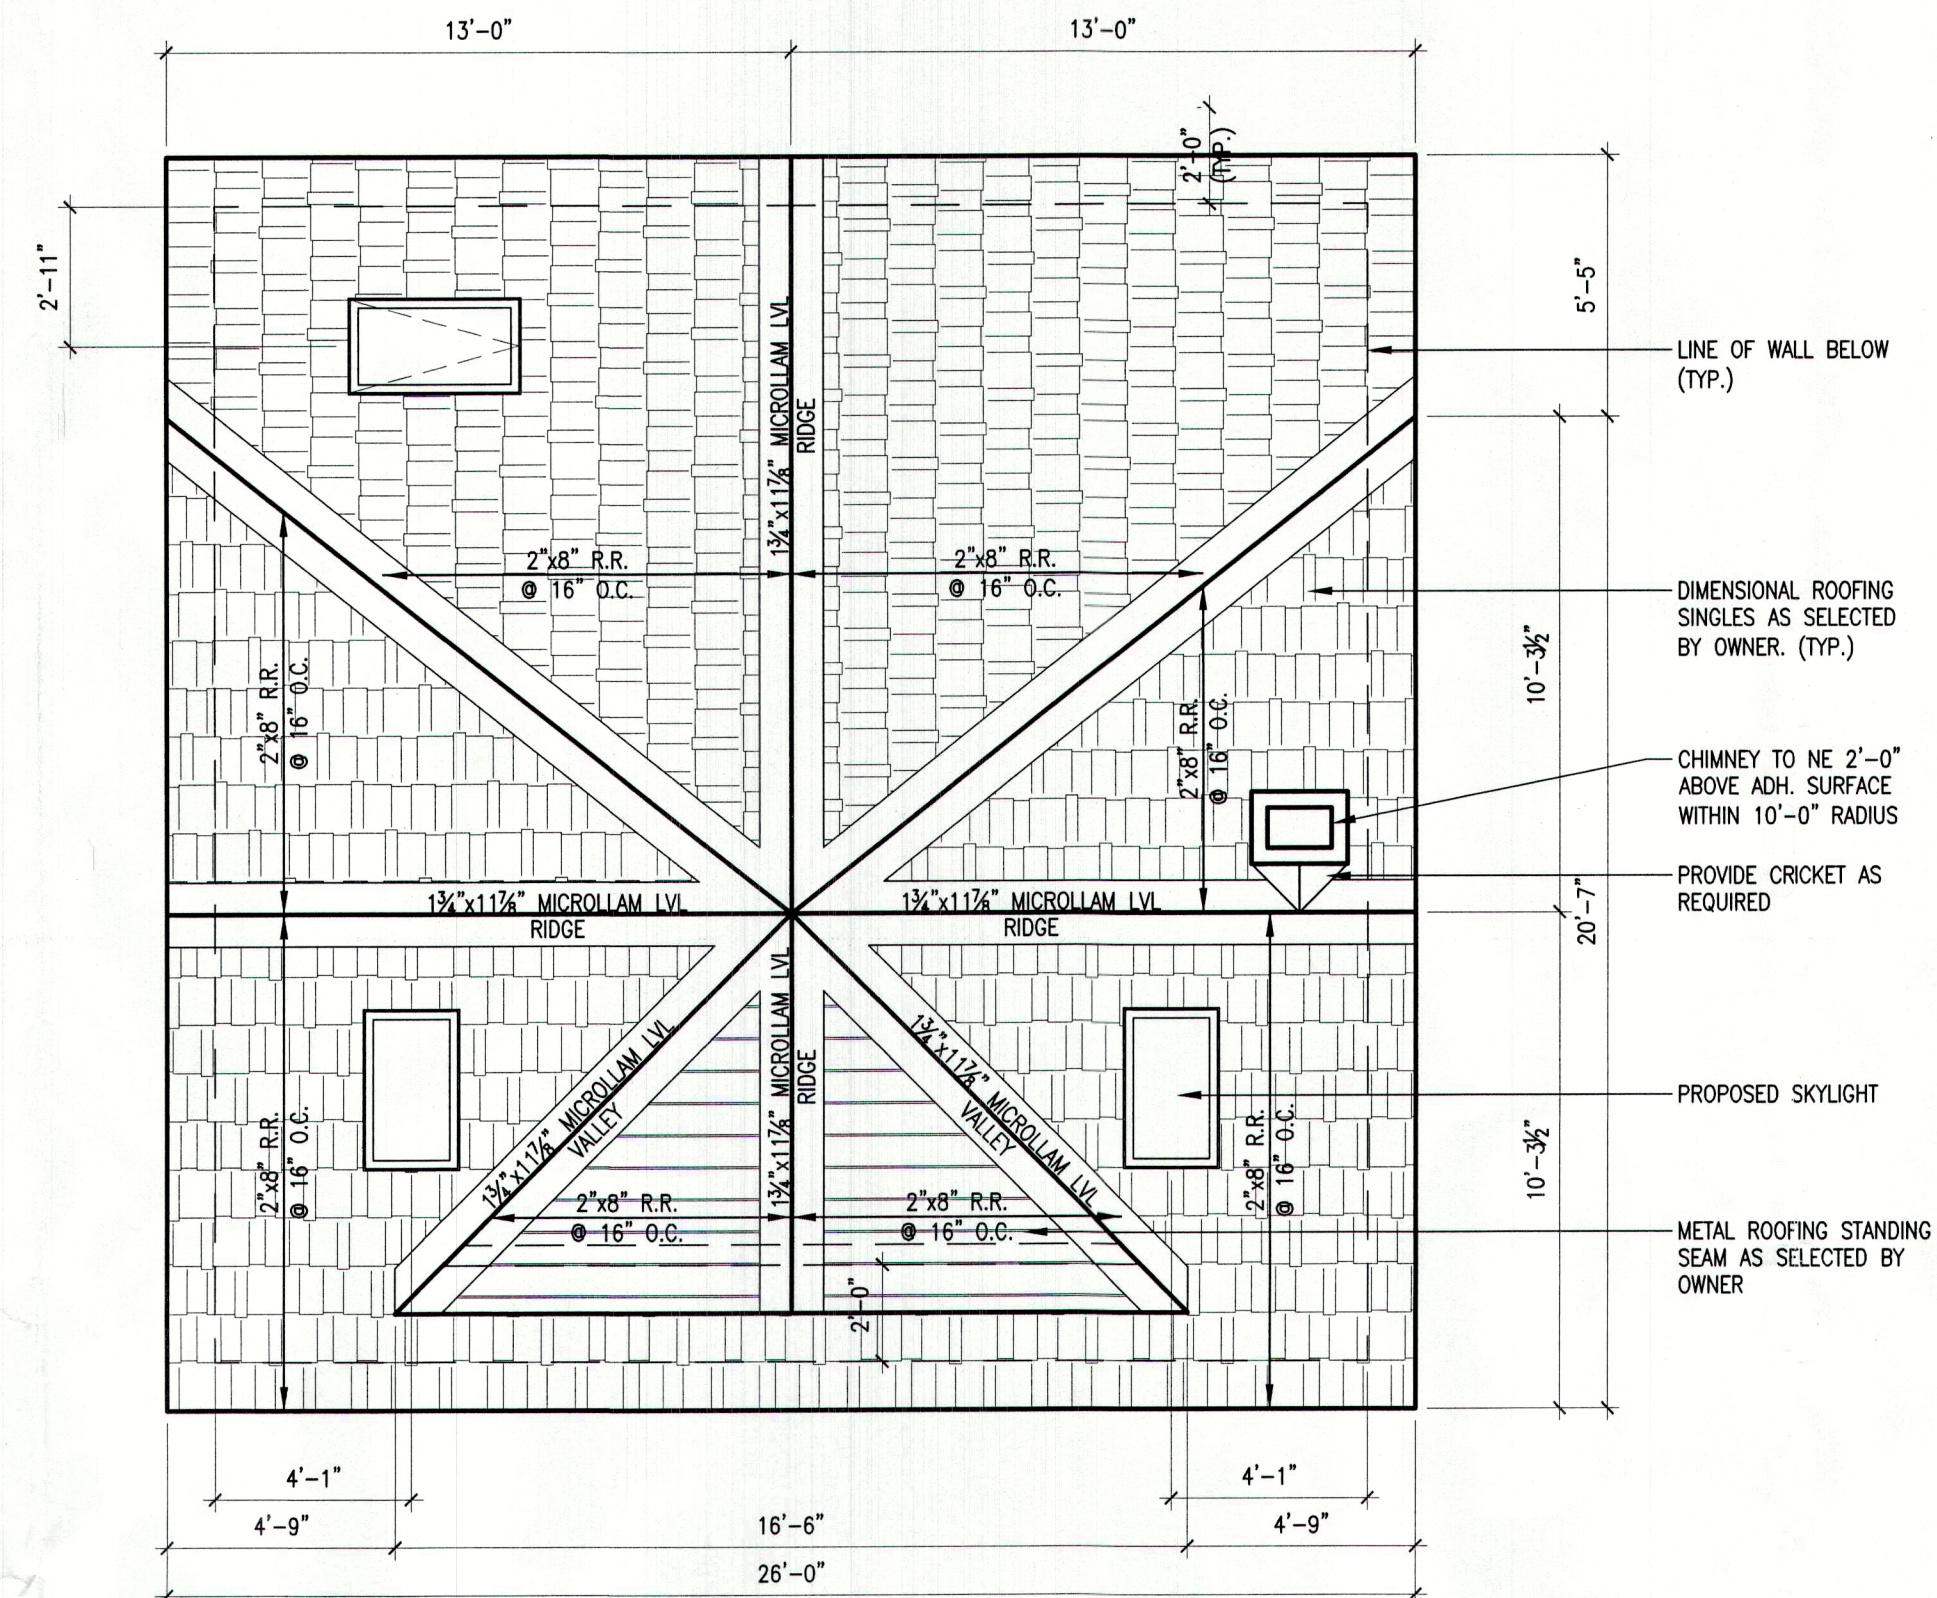


02 ROOF PLAN

SCALE: 1/4" = 1'-0"

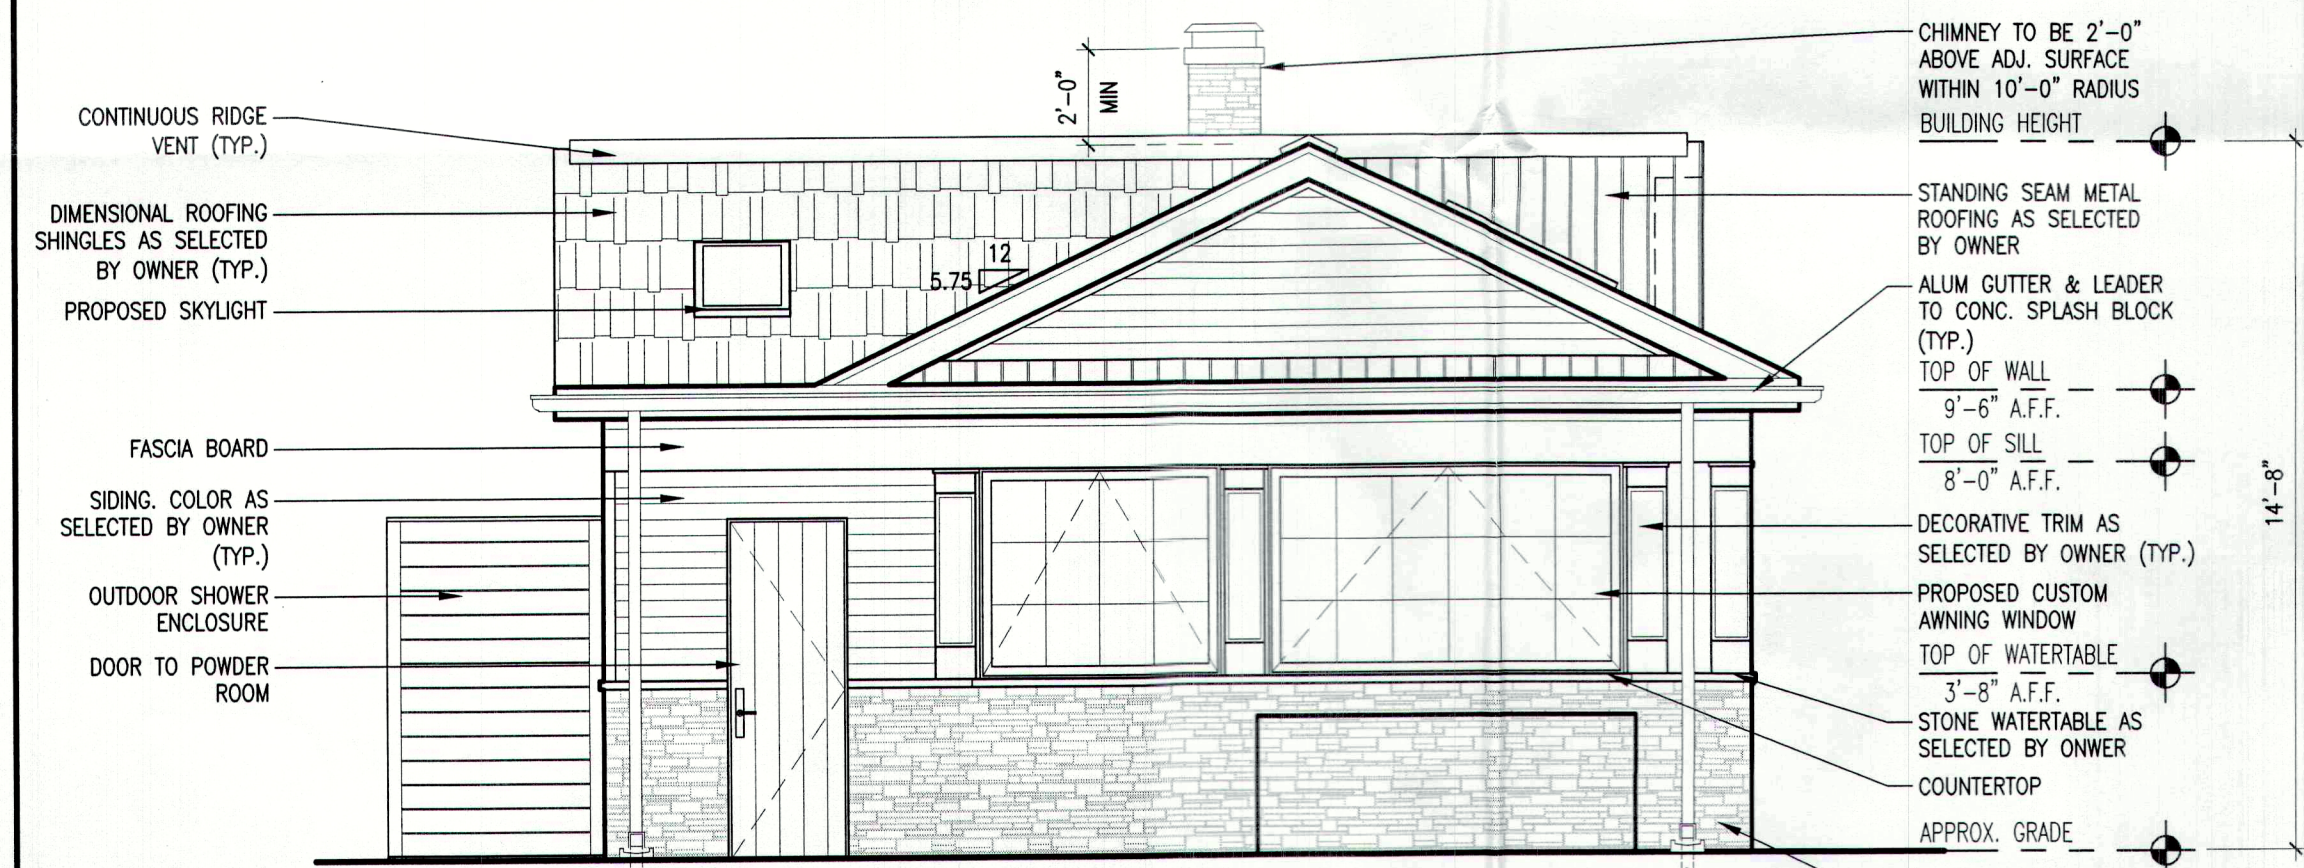


03 LEFT SIDE ELEVATION

SCALE: 1/4" = 1'-0"

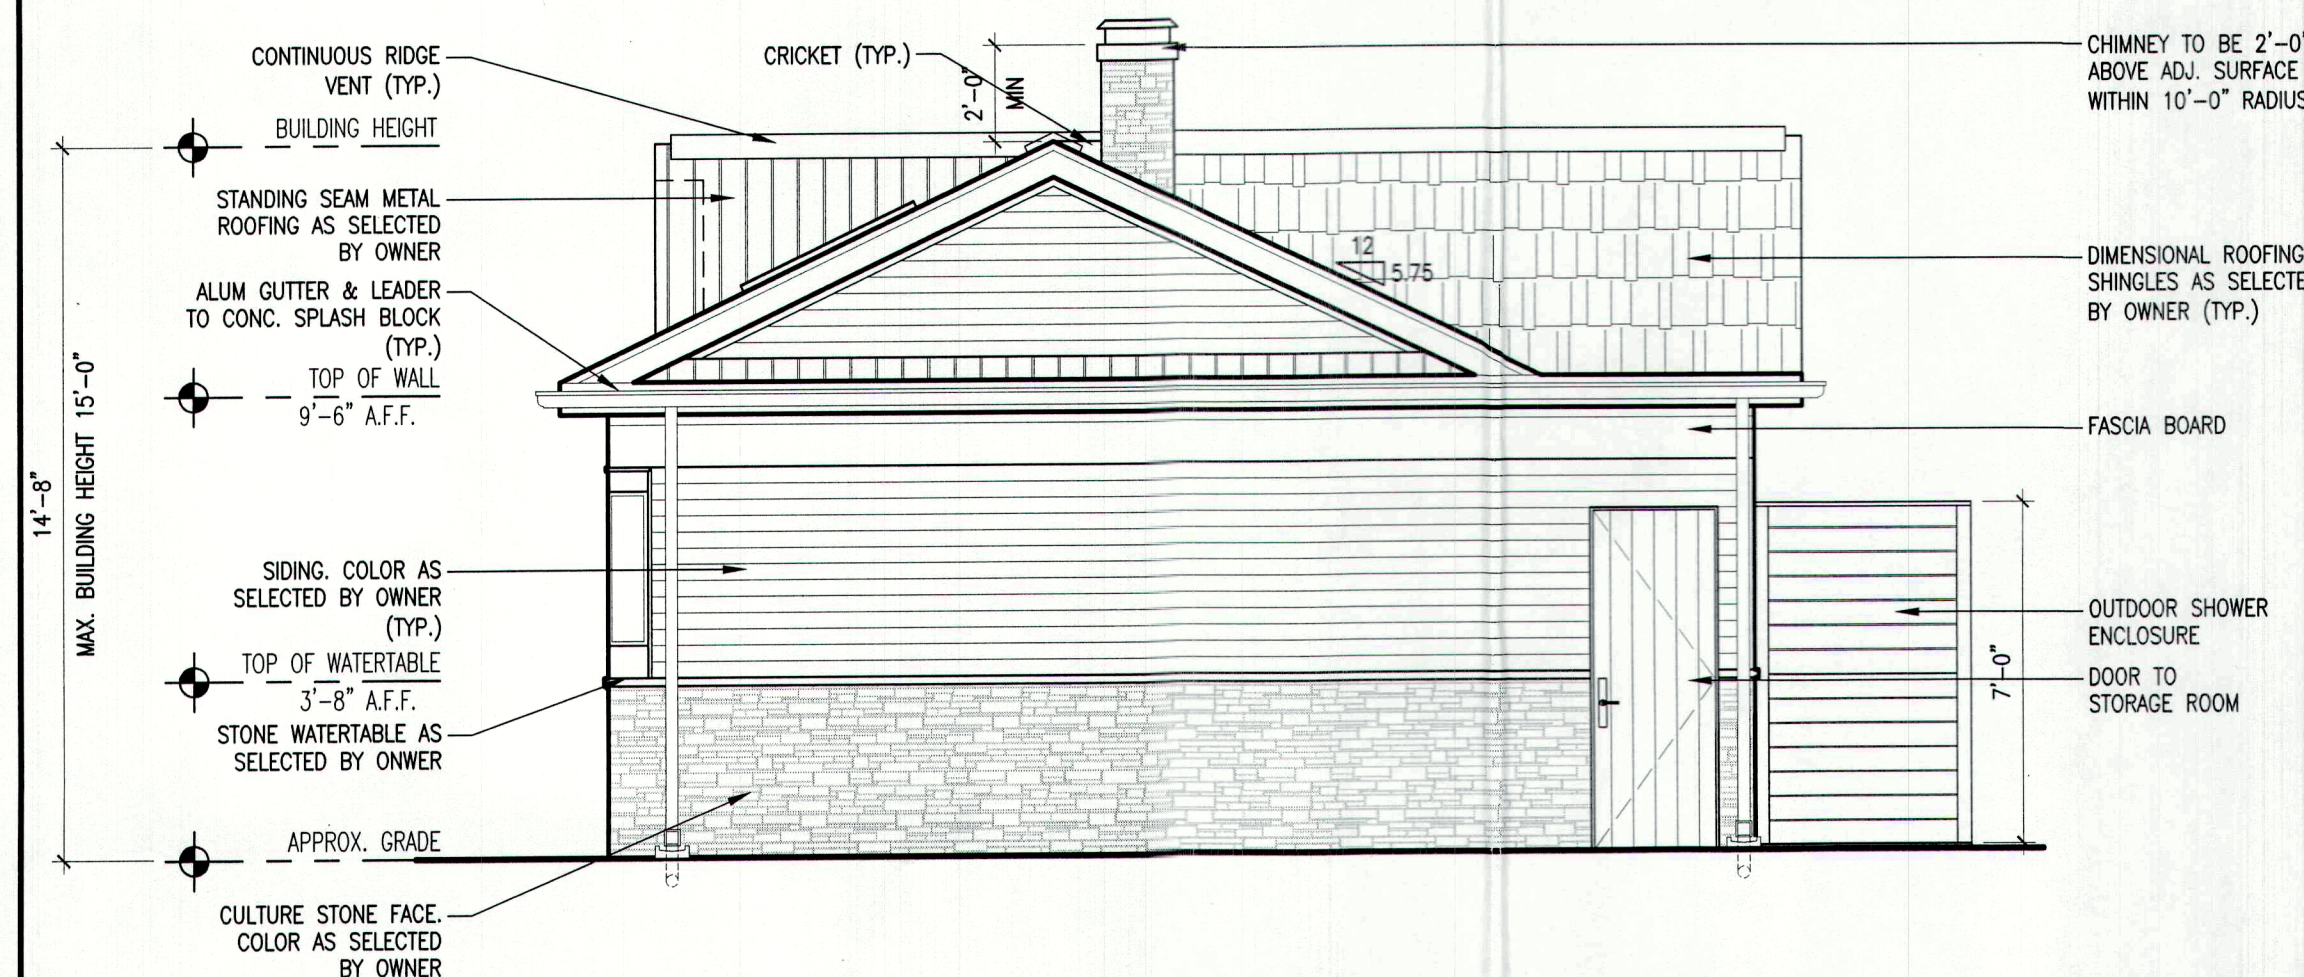

04 RIGHT SIDE ELEVATION

SCALE: 1/4" = 1'-0"

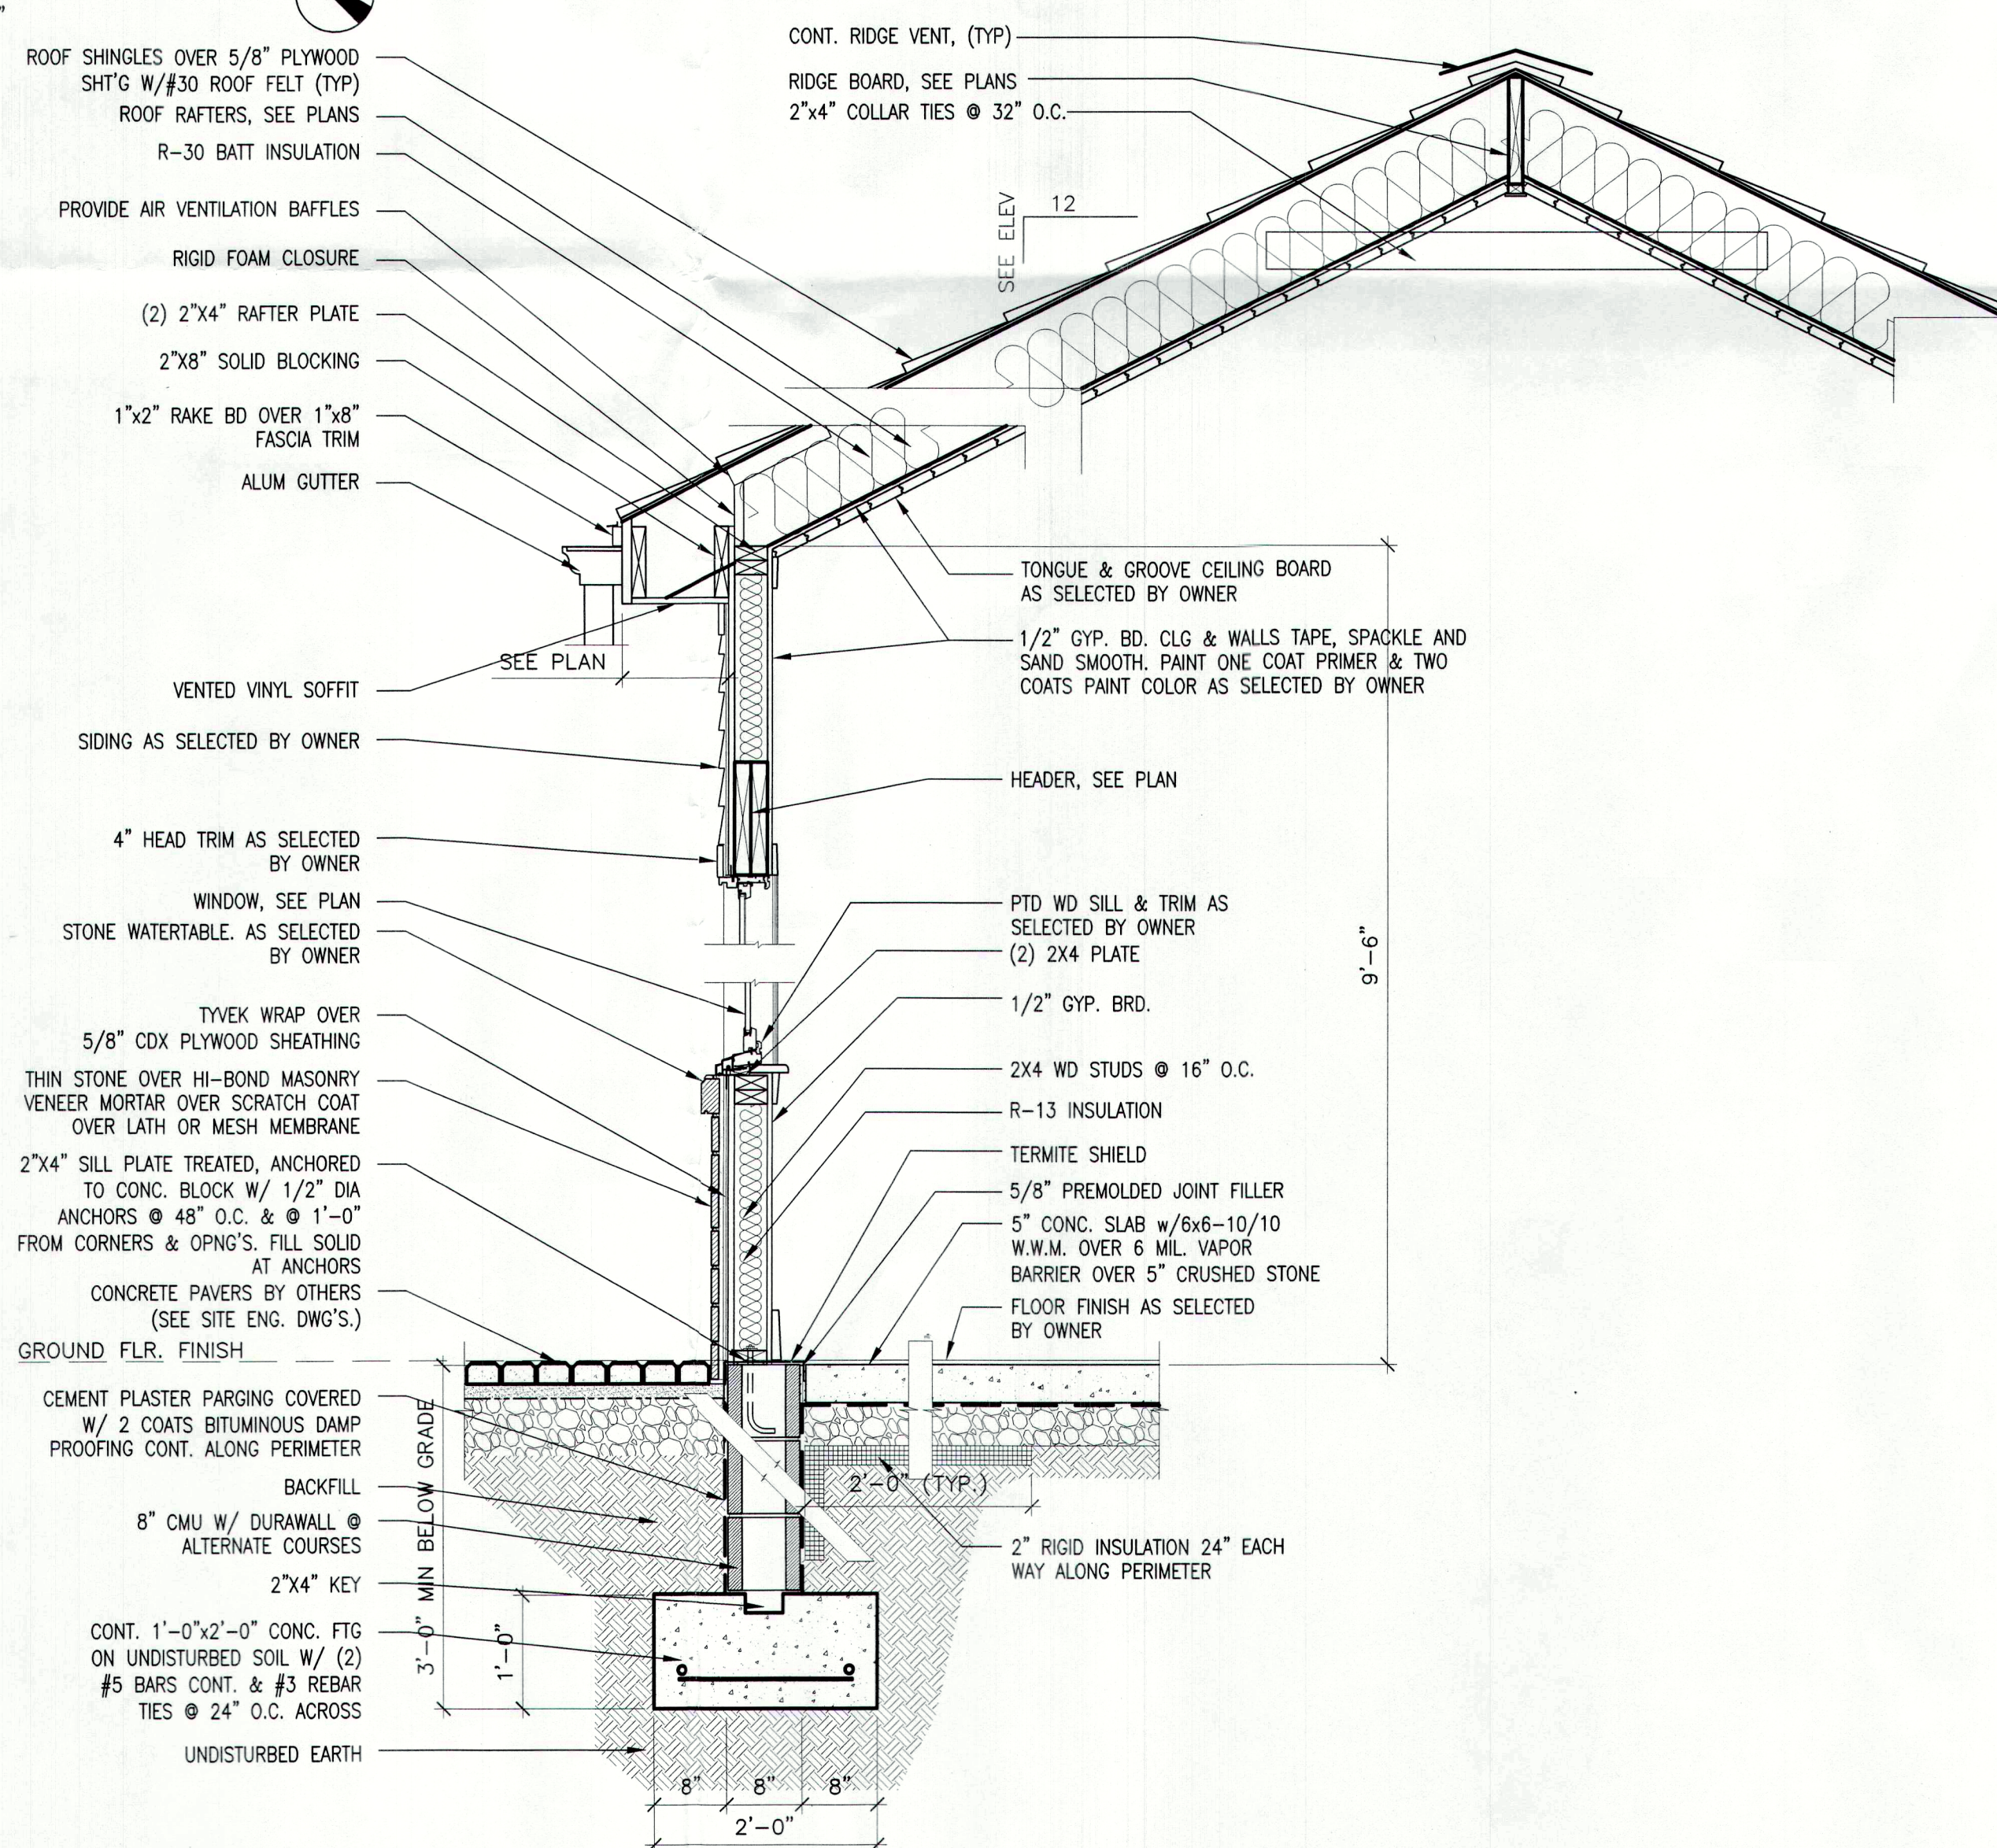


05 WALL SECTION

SCALE: 3/4" = 1'-0"

CONSTRUCTION LEGEND	
	NEW WALL CONSTRUCTION 2"x4" WOOD STUDS @ 16" O.C. U.O.N.
	NEW BRICK FACING AS SELECTED BY OWNER
	NEW CONCRETE BLOCK WALL CONSTRUCTION

ELECTRICAL LEGEND	
SYMBOL	DESCRIPTION
	INTERIOR GRADE SURFACE MTD. LIGHT FIXTURE
	EXTERIOR GRADE SURFACE MTD. LIGHT FIXTURE
	SINGLE POLE LIGHT SWITCH
	THREE WAY LIGHT SWITCH
	FOUR WAY LIGHT SWITCH
	DUPLEX RECEPTACLE OUTLET
	DUPLEX RECEPTACLE OUTLET GROUND FAULT INTERRUPT
	WEATHER PROOF DUPLEX RECEPTACLE OUTLET
	SMOKE/CARBON MONOXIDE DETECTOR HARD WIRED W/BATTERY PACK
	EXHAUST FAN/LIGHT FIXTURE COMB.
	CEILING FAN
	WALL MOUNTED LIGHT FIXTURE
	1'x4' FLOURECENT STRIP LIGHT FIXTURE
	PENDANT LIGHT FIXTURE
	EXTERIOR LIGHT FIXTURE W/MOTION SENSOR

PLUMBING LEGEND	
SYMBOL	DESCRIPTION
	HOSE BIBB
	NOTE: FROST PROTECT OR ENABLE DRAINBACK IN WINTER TO PROTECT FROM FREEZING

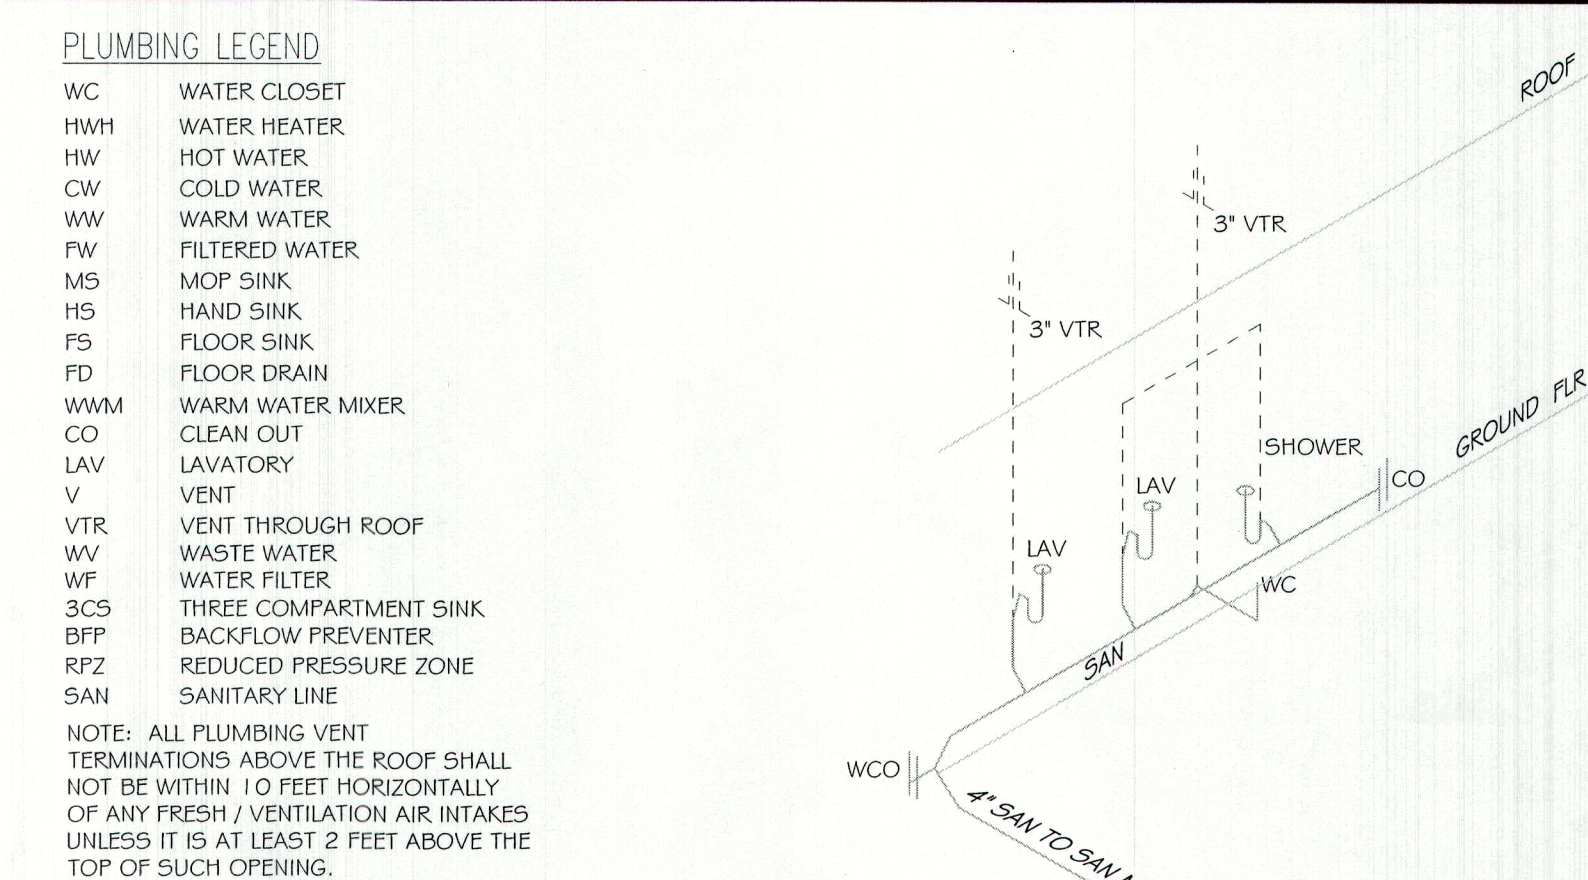


06 SANITARY RISER DIAGRAM

SCALE: N.T.S.


PLUMBING FIXTURE SIZING SCHEDULE

NO	EQUIPMENT	CW	HW	GAS	WASTE	SANITARY	INDIRECT WASTE	VENT
1	LAVATORY	1/2"	1/2"	-	1 1/2"	-	-	1 1/2"
2	WATER CLOSET	1/2"	-	-	3"	-	-	1 1/2"
3	SHOWER	1/2"	1/2"	-	2"	-	-	1 1/2"
4	SINK	1/2"	1/2"	-	2"	-	-	1 1/2"

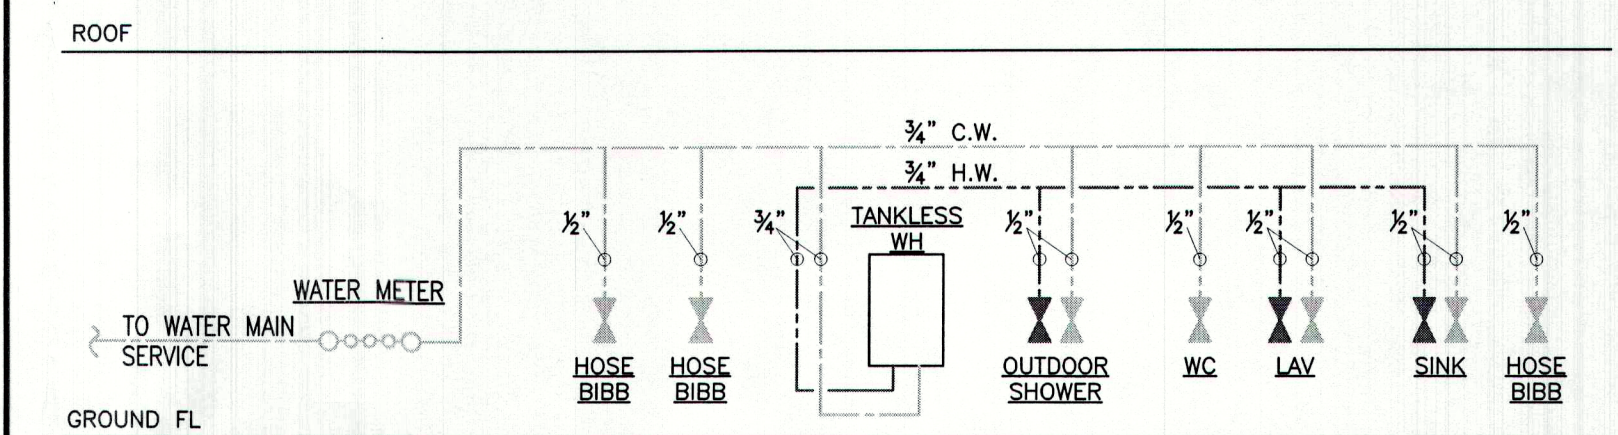

07 WATER SUPPLY RISER DIAGRAM

SCALE: N.T.S.

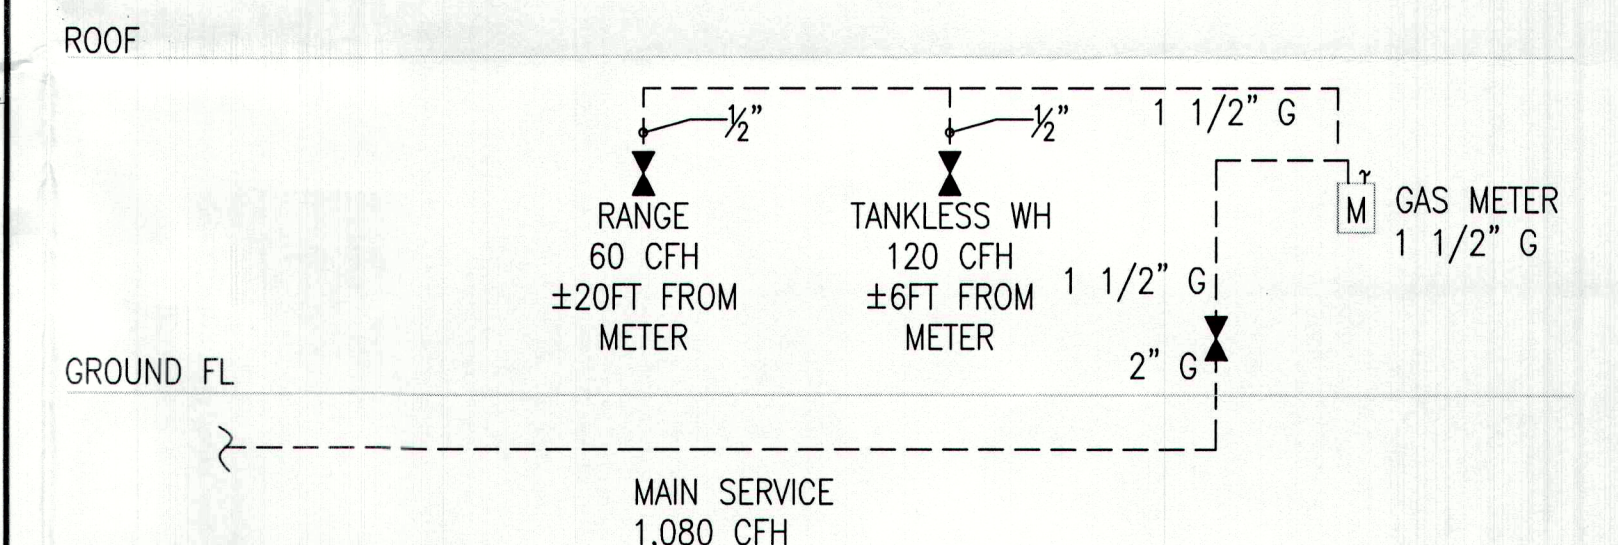

08 GAS SUPPLY RISER DIAGRAM

SCALE: N.T.S.

No.	Date:	Revision:

HERITAGE MADISON ARCHITECTURE, L.L.C.
Architecture Design Interiors
1171 Madison Ave., Suite 201
Paterson, N.J. 07503
Tel: (973) 689 8780
Fax: (862) 239 1888
admin@hmalc.net www.hmalc.net

Project No:	23122	Project:	PROPOSED CABANA
Date:	Oct. 12, 2023		
Block:	68		
Lot:	14.01		
Scale:	AS NOTED		
Drawn By:			
Checked By:			
		Drawing title:	Floor Plan (Electrical), Roof Plan, Elevations, Wall Section, Plumbing Riser Diagrams, Legend, Notes

Seal:
Nassir Almkhtar, RA
NJ Lic. # 16036
NY Lic. # 030342

Drawing No:
A-01

© Heritage Madison Architecture, L.L.C.